



DREAMBUILDER
CUSTOM HOMES, LLC

DREAMBUILDER 27

LAW RESIDENCE

REVISIONS			ABBREVIATIONS			GENERAL NOTES			INDEX		
DATE	MARK	DESCRIPTION	A.B. Abv. A/C Adj. A.F.F. A.H.U. ALT. B.C. B.F. Bk Sh Bm. BOT. B.P. Brg. Cir. Ctg. CJ Col. Comp. C.T. D Dec. Ded. Dbl. Dia. Disp. Dist. D.S. D.V. D.W. Ea. E.W. Elec. Elev. Ext. Exp. F.B.C. Fin. Flr. F.G. Flr. Fdn. Flr. Sys. F.Pl. F.O.M. FL Ftg. FX Galv.	Anchor Bolt Above Air-Conditioner Adjustable Above Finished Floor Air Handler Unit Alternate Base Cabinet Bifold Door Book Shelf Beam Bottom Bypass door Bearing Circle Ceiling Control Joint Column A/C Compressor Ceramic Tile Dryer Decorative Dedicated Outlet Double Diameter Disposal Distance Drawer Stack Dryer Vent Dishwasher Each Each Way Electrical Elevation Exterior Expansion Florida Bldg. Code Finished Floor Fixed Glass Floor Foundation Floor System Fireplace Face Of Masonry Foot / Feet Footing Fixed Galvanized	G.C. G.F.I. G.T. Hdr. Hgt. HB Int. K/Vall K.S. Laun. Lav. L.F. L.T. Mas. Max M.C. Mfg. Micro. Min M.L. Mir. Monolithic N.T.S. N.T.S. Opt. Pc. Ped. P.L. PLF Plt. Ht. Plt. Sh. PSF P.T. Pwd. Rad. Ref. Req'd. Rm. Rnd. R/S SD. S.F. Sh. SHT S.L. S.P.F. Sq. S.W.H S.Y.P.	General Contractor Ground Fault Interrupter Girder Truss Header Height Hose Bibb Interior Kneewall Knee Space Laundry Lavatory Linear FL Laundry Tub Masonry Maximum Medicine Cabinet Manufacturer Microwave Minimum Microlam Mirror Monolithic Not to Scale Opening Optional Piece Pedestal Parallam Pounds per linear foot Plate Height Plant Shelf Pounds per square foot Pressure Treated Powder Room Radius Refrigerator Required Room Round Rod and Shelf Smoke Detector Square Ft. Shelves Sheet Side Lights Spruce Pine Fir Square SHOWER HEAD Southern Yellow Pine	Temp. Thickn. T.O.B. T.O.M. T.O.P. Trans. Typ. U.C. UCL U.N.O. VB Vert. V.L. VTR W W/ W/C W.A. Wd WP	Tempered Thicken Top of Block Top of Masonry Top of Plate Transom Window Typical Under Counter Under Cabinet Lighting Unless Noted Otherwise Vanity Base Vertical Versalam Vent through Roof Washer With Water Closet Wedge Anchor Wood Water Proof	1. ALL EXTERIOR WALLS SHALL BE ASSUMED TO BE LOAD BEARING. SEE STRUCTURAL FLOOR PLAN AND FOUNDATION PLAN FOR WALL REINFORCEMENT LOCATIONS. 2. WINDOW AND DOOR SUPPLIERS SHALL PROVIDE CURRENT ROUGH OPENING INFO WHICH SHALL HAVE PRECEDENCE OVER THE WINDOW AND DOORS LABELED ON PLAN. 3. CABINET MFRS. SHOP DRAWINGS SHALL HAVE PRECEDENCE OVER THE INTERIOR CABINET ELEVATIONS SHOWN. 4. DO NOT SCALE PLANS. DIMENSIONS ARE TO BE FOLLOWED AS NOTED. 5. ALL GLASS LOCATED IN HAZARDOUS LOCATIONS SHALL COMPLY WITH SECTION R308 OF THE FLORIDA BUILDING CODE RESIDENTIAL. 6. INTERIOR TO GARAGE DOOR MUST BE EITHER 1-3/8" SOLID WOOD, SOLID OR HONEYCOMB STEEL, OR 20 MIN. FIRE RATED DOOR. 7. DRYER VENTS TO BE PLACED BEHIND THE DRYER LOCATION AND TO BE NO MORE THAN 25'-0" LONG. 8. IF WATER BASED CEILING TEXTURE MATERIAL IS USED, PROVIDE 1/2" GYPSUM BOARD FOR 16" O.C. FRAMING, OR 5/8" GYPSUM BOARD FOR 24" O.C. FRAMING. NOTE: 1/2" SAG-RESISTANT GYPSUM BOARD MAY BE USED I.L.O. OF 5/8" GYPSUM. 9. THE GARAGE SHALL BE SEPARATED FROM THE RESIDENCE AND ITS ATTIC AREA BY NOT LESS THAN 3/4-INCH (12.7 MM) GYPSUM BOARD APPLIED TO THE GARAGE SIDE. GARAGES BENEATH HABITABLE ROOMS SHALL BE SEPARATED FROM ALL HABITABLE ROOMS ABOVE BY NOT LESS THAN 5/8-INCH (15.9 MM) TYPE X GYPSUM BOARD OR EQUIVALENT WHERE THE SEPARATION IS A FLOOR-CEILING ASSEMBLY. THE STRUCTURE SUPPORTING THE SEPARATION SHALL ALSO BE PROTECTED BY NOT LESS THAN 3/4-INCH (12.7 MM) GYPSUM BOARD OR EQUIVALENT. 10. ANY ACCESSIBLE SPACE UNDER A STAIRWAY SHALL BE PROTECTED WITH 1/2" GYPSUM. 11. ATTIC ACCESS- PROVIDE 20 MIN. FIRE RATING AT ACCESS PANEL. 12. DUCTS IN THE GARAGE AND DUCTS PENETRATING THE WALLS OR CEILINGS SEPARATING THE DWELLING FROM THE GARAGE SHALL BE CONSTRUCTED OF A MINIMUM NO. 26 GAGE (0.48 MM) SHEET STEEL, 1 INCH MINIMUM RIGID NONMETALLIC CLASS I OR CLASS II DUCT BOARD, OR OTHER APPROVED MATERIAL AND SHALL HAVE NO OPENINGS INTO THE GARAGE. CURRENT BUILDING CODE..... FLORIDA BUILDING CODE 2010 RESIDENTIAL OCCUPANCY CLASSIFICATION..... GROUP R3 CONSTRUCTION TYPE.....5B		
-CONTRACTOR: DREAMBUILDER CUSTOM HOMES SHAWN STARR SHAWN@YOURDREAMBUILDER.COM (904)612-6946 -ENGINEER: LOU PONTIGO & ASSOCIATES LOU PONTIGO LOU@LP-A.COM 904-242-0908			-INTERIOR DESIGNER: MS J DESIGN JOSIE MYRES MSJDESIGNINC@AOL.COM (904)535-1981 -DRAWN BY: PATRICK MANGUS 2023 OLD TMYE. AVE. ST. AUGUSTINE, FLA. 32084 904-810-5904			DATE: 12-17-14			DRAWING INDEX		
									Sheet # SHEET TITLE		
									COVER PAGE		
						SITE SITE PLAN					
						S-1 NOTES PAGE					
						F-1 FOUNDATION PLAN					
						A-1 FLOOR PLAN					
						A-2 ELEVATIONS					
						A-3 ROOF LAYOUT					
						A-4 FLOORING LAYOUT					
						D-1 DETAILS					
						E-1 ELECTRICAL PLAN					
						SPECS					
						AREA EVALUATION					
						FIRST FLOOR 4063 SQ FT					
						TOTAL LIVING 4063 SQ FT					
						GARAGE 1271 SQ FT					
						COV. ENTRY (FRONT) 109 SQ FT					
						COV. PORCH (REAR) 546 SQ FT					
						TOTAL UNDER ROOF 5989 SQ FT					

S1					A CUSTOM HOME FOR:				PLAN														
	DREAMBUILDER CUSTOM HOMES, LLC				THE LAW FAMILY				DREAMBUILDER 27														
	DRAWN PM		CHECKED XXX						1060 OAKVALE RD.														
	SCALE 1/4"=1'-0"								FRUIT COVE, FL.														
	DATE: 7/7/14								32259														
	CHANGES				M/D/Y																		
	REV. DATE																						
	REV. DATE																						
	JOB NO. XXX																						
	SHEET NUMBER																						
TRADE STRUCT.				VENDOR		TRADE A/C		VENDOR		TRADE SURVEYOR		M/D/Y		VENDOR		M/D/Y		CONCRETE DRIVEWAY:		SQUARE ENTRY WALK:		FOOTAGES (±) STREET WALK:	
						M/D/Y												905		98		XXXX	
						LANDSCAPE																	

DRAWN BY: PATRICK MANGUS
2023 OLD TMYE. AVE. ST.
AUGUSTINE, FLA. 32084
904-810-5904
DATE: 2-29-12

MAIN SLAB
 4" CONCRETE SLAB W/ 606 100 WMM
 AND SMALL VEGEEN WAPER BARRIER
 ON ALL CONCRETE SLAB AND SOIL
 (TYPICAL ALL SLAB AREAS)
 SLAB ON 3 COURSE STEEL WALL
 FFE=7.5'

Notes:
 1. PROVIDE LINE & GRAVITY DRAIN FOR ICE MAKER
 2. PROVIDE ELEC. FOR ISLAND
 3. 4"x4" STOP L.V. W/ SLOPE FORM & POUR STEPS
 4. GAS TANKLESS WITH FORM AND POUR STEPS
 5. A/C
 6. CEN.

Dimensions:
 Overall dimensions: 117'-6" (width), 79'-5" (depth).
 Room dimensions include: 11'-0", 17'-2", 20'-2", 3'-0", 3'-11", 15'-3", 20'-2", 3'-0", 2'-6", 1'-11", 12'-9", 4'-10", 3'-6", 5'-11", 7'-3", 1'-6", 1'-11", 4'-10", 7'-6", 3'-11", 5'-11", 8'-6", 16'-2", 1'-11", 16'-2", 1'-11", 2'-6", 13'-7", 25'-6", 17'-6", 35'-6", 2'-0", 20'-0", 26'-1", 117'-6", 2'-0", 19'-0", 12'-1", 17'-7", 3'-3", 11'-0", 4'-5", 3'-3", 6'-11", 6'-8", 24'-6", 10'-0", 12'-5", 9'-2", 7'-11", 12'-5", 11'-3", 7'-5", 6'-5", 15'-8", 3'-1", 3'-4", 14'-5", 32'-11", 8'-0", 3'-0", 3'-0", 68'-0", 16'-0", 24'-6", 11'-11", 13'-7", 2'-6", 17'-6", 35'-6", 2'-0", 20'-0", 26'-1", 117'-6", 2'-0", 19'-0", 12'-1", 17'-7", 3'-3", 11'-0", 4'-5", 3'-3", 6'-11", 6'-8", 24'-6", 10'-0", 12'-5", 9'-2", 7'-11", 12'-5", 11'-3", 7'-5", 6'-5", 15'-8", 3'-1", 3'-4", 14'-5", 32'-11", 8'-0", 3'-0", 3'-0", 68'-0", 16'-0", 24'-6", 11'-11", 13'-7", 2'-6", 17'-6", 35'-6", 2'-0", 20'-0", 26'-1", 117'-6", 2'-0", 19'-0", 12'-1", 17'-7", 3'-3", 11'-0", 4'-5", 3'-3", 6'-11", 6'-8", 24'-6", 10'-0", 12'-5", 9'-2", 7'-11", 12'-5", 11'-3", 7'-5", 6'-5", 15'-8", 3'-1", 3'-4", 14'-5", 32'-11", 8'-0", 3'-0", 3'-0", 68'-0", 16'-0", 24'-6", 11'-11", 13'-7", 2'-6", 17'-6", 35'-6", 2'-0", 20'-0", 26'-1", 117'-6", 2'-0", 19'-0", 12'-1", 17'-7", 3'-3", 11'-0", 4'-5", 3'-3", 6'-11", 6'-8", 24'-6", 10'-0", 12'-5", 9'-2", 7'-11", 12'-5", 11'-3", 7'-5", 6'-5", 15'-8", 3'-1", 3'-4", 14'-5", 32'-11", 8'-0", 3'-0", 3'-0", 68'-0", 16'-0", 24'-6", 11'-11", 13'-7", 2'-6", 17'-6", 35'-6", 2'-0", 20'-0", 26'-1", 117'-6", 2'-0", 19'-0", 12'-1", 17'-7", 3'-3", 11'-0", 4'-5", 3'-3", 6'-11", 6'-8", 24'-6", 10'-0", 12'-5", 9'-2", 7'-11", 12'-5", 11'-3", 7'-5", 6'-5", 15'-8", 3'-1", 3'-4", 14'-5", 32'-11", 8'-0", 3'-0", 3'-0", 68'-0", 16'-0", 24'-6", 11'-11", 13'-7", 2'-6", 17'-6", 35'-6", 2'-0", 20'-0", 26'-1", 117'-6", 2'-0", 19'-0", 12'-1", 17'-7", 3'-3", 11'-0", 4'-5", 3'-3", 6'-11", 6'-8", 24'-6", 10'-0", 12'-5", 9'-2", 7'-11", 12'-5", 11'-3", 7'-5", 6'-5", 15'-8", 3'-1", 3'-4", 14'-5", 32'-11", 8'-0", 3'-0", 3'-0", 68'-0", 16'-0", 24'-6", 11'-11", 13'-7", 2'-6", 17'-6", 35'-6", 2'-0", 20'-0", 26'-1", 117'-6", 2'-0", 19'-0", 12'-1", 17'-7", 3'-3", 11'-0", 4'-5", 3'-3", 6'-11", 6'-8", 24'-6", 10'-0", 12'-5", 9'-2", 7'-11", 12'-5", 11'-3", 7'-5", 6'-5", 15'-8", 3'-1", 3'-4", 14'-5", 32'-11", 8'-0", 3'-0", 3'-0", 68'-0", 16'-0", 24'-6", 11'-11", 13'-7", 2'-6", 17'-6", 35'-6", 2'-0", 20'-0", 26'-1", 117'-6", 2'-0", 19'-0", 12'-1", 17'-7", 3'-3", 11'-0", 4'-5", 3'-3", 6'-11", 6'-8", 24'-6", 10'-0", 12'-5", 9'-2", 7'-11", 12'-5", 11'-3", 7'-5", 6'-5", 15'-8", 3'-1", 3'-4", 14'-5", 32'-11", 8'-0", 3'-0", 3'-0", 68'-0", 16'-0", 24'-6", 11'-11", 13'-7", 2'-6", 17'-6", 35'-6", 2'-0", 20'-0", 26'-1", 117'-6", 2'-0", 19'-0", 12'-1", 17'-7", 3'-3", 11'-0", 4'-5", 3'-3", 6'-11", 6'-8", 24'-6", 10'-0", 12'-5", 9'-2", 7'-11", 12'-5", 11'-3", 7'-5", 6'-5", 15'-8", 3'-1", 3'-4", 14'-5", 32'-11", 8'-0", 3'-0", 3'-0", 68'-0", 16'-0", 24'-6", 11'-11", 13'-7", 2'-6", 17'-6", 35'-6", 2'-0", 20'-0", 26'-1", 117'-6", 2'-0", 19'-0", 12'-1", 17'-7", 3'-3", 11'-0", 4'-5", 3'-3", 6'-11", 6'-8", 24'-6", 10'-0", 12'-5", 9'-2", 7'-11", 12'-5", 11'-3", 7'-5", 6'-5", 15'-8", 3'-1", 3'-4", 14'-5", 32'-11", 8'-0", 3'-0", 3'-0", 68'-0", 16'-0", 24'-6", 11'-11", 13'-7", 2'-6", 17'-6", 35'-6", 2'-0", 20'-0", 26'-1", 117'-6", 2'-0", 19'-0", 12'-1", 17'-7", 3'-3", 11'-0", 4'-5", 3'-3", 6'-11", 6'-8", 24'-6", 10'-0", 12'-5", 9'-2", 7'-11", 12'-5", 11'-3", 7'-5", 6'-5", 15'-8", 3'-1", 3'-4", 14'-5", 32'-11", 8'-0", 3'-0", 3'-0", 68'-0", 16'-0", 24'-6", 11'-11", 13'-7", 2'-6", 17'-6", 35'-6", 2'-0", 20'-0", 26'-1", 117'-6", 2'-0", 19'-0", 12'-1", 17'-7", 3'-3", 11'-0", 4'-5", 3'-3", 6'-11", 6'-8", 24'-6", 10'-0", 12'-5", 9'-2", 7'-11", 12'-5", 11'-3", 7'-5", 6'-5", 15'-8", 3'-1", 3'-4", 14'-5", 32'-11", 8'-0", 3'-0", 3'-0", 68'-0", 16'-0", 24'-6", 11'-11", 13'-7", 2'-6", 17'-6", 35'-6", 2'-0", 20'-0", 26'-1", 117'-6", 2'-0", 19'-0", 12'-1", 17'-7", 3'-3", 11'-0", 4'-5", 3'-3", 6'-11", 6'-8", 24'-6", 10'-0", 12'-5", 9'-2", 7'-11", 12'-5", 11'-3", 7'-5", 6'-5", 15'-8", 3'-1", 3'-4", 14'-5", 32'-11", 8'-0", 3'-0", 3'-0", 68'-0", 16'-0", 24'-6", 11'-11", 13'-7", 2'-6", 17'-6", 35'-6", 2'-0", 20'-0", 26'-1", 117'-6", 2'-0", 19'-0", 12'-1", 17'-7", 3'-3", 11'-0", 4'-5", 3'-3", 6'-11", 6'-8", 24'-6", 10'-0", 12'-5", 9'-2", 7'-11", 12'-5", 11'-3", 7'-5", 6'-5", 15'-8", 3'-1", 3'-4", 14'-5", 32'-11", 8'-0", 3'-0", 3'-0", 68'-0", 16'-0", 24'-6", 11'-11", 13'-7", 2'-6", 17'-6", 35'-6", 2'-0", 20'-0", 26'-1", 117'-6", 2'-0", 19'-0", 12'-1", 17'-7", 3'-3", 11'-0", 4'-5", 3'-3", 6'-11", 6'-8", 24'-6", 10'-0", 12'-5", 9'-2", 7'-11", 12'-5", 11'-3", 7'-5", 6'-5", 15'-8", 3'-1", 3'-4", 14'-5", 32'-11", 8'-0", 3'-0", 3'-0", 68'-0", 16'-0", 24'-6", 11'-11", 13'-7", 2'-6", 17'-6", 35'-6", 2'-0", 20'-0", 26'-1", 117'-6", 2'-0", 19'-0", 12'-1", 17'-7", 3'-3", 11'-0", 4'-5", 3'-3", 6'-11", 6'-8", 24'-6", 10'-0", 12'-5", 9'-2", 7'-11", 12'-5", 11'-3", 7'-5", 6'-5", 15'-8", 3'-1", 3'-4", 14'-5", 32'-11", 8'-0", 3'-0", 3'-0", 68'-0", 16'-0", 24'-6", 11'-11", 13'-7", 2'-6", 17'-6", 35'-6", 2'-0", 20'-0", 26'-1", 117'-6", 2'-

 DREAMBUILDER CUSTOM HOMES, LLC	A CUSTOM HOME FOR: <i>THE LAW FAMILY</i>		PLAN <i>DREAMBUILDER 27</i>									
	TO BE BUILT AT: <i>1060 OAKVALE RD</i>		1060 OAKVALE RD. FRONT COVE, FL. 32259									
DRAWN PM CHECKED XXXX SCALE 1/4" = 1'-0" DATE: 7/7/14 CHANGES 12/17/14 REV. DATE REV. DATE REV. DATE JOB NO. XXX	TRADE	VENDOR	M/D/Y	TRADE	VENDOR	M/D/Y	TRADE	VENDOR	M/D/Y	CONCRETE	SQUARE	FOOTAGES (±)
	A/C			LANDSCAPE			SLURVEYOR			DRIVEWAY:	905	ENTREY WALK:
	TRADE	VENDOR		TRADE	VENDOR		STREET	WALK:				XXXX
	TRADE	VENDOR		STRICT								

PLAN	
<i>DREAMBUILDER 27</i>	
DATE	SQUARE FOOTAGES (±)
Y. WALK	98
WALK	STREET WALK
	XXXX

A CUSTOM HOME FOR: *THE LAW FAMILY*

TO BE BUILT AT: *1060 OAKVALE RD*

1060 OAKVALE RD.
FRUIT COVE, FL.
32259

DOOR	M/D/Y	TRADE	VENDOR	M/D/Y	CONF
		SURVEYOR			DRIVEWAY: 905
					CON

DREAMBUILDER
CUSTOM HOMES, LLC

DRAWN PM	CHECKED XXX	M/D/Y	VENDOR	TRADE STRUCT.
SCALE 1/4"=1'-0"				
DATE: 7/7/14				
CHANGES 12/17/14				
REV. DATE				
REV. DATE				
JOB NO. XXX				
SHEET NUMBER				
F-1				

[illegible]

AREA EVALUATION	
FIRST FLOOR	4063 SQ FT
TOTAL LIVING	4063 SQ FT
GARAGE	1271 SQ FT
COV. ENTRY (FRONT)	109 SQ FT
COV. PORCH (REAR)	546 SQ FT
TOTAL UNDER ROOF	5989 SQ FT



DREAMBUILDER
CUSTOM HOMES, LLC

DRAWN: _____ CHECKED: _____
PM: _____ XXX: _____

SCALE: _____
1/4"=1'-0"

DATE: 7/7/14

REV. DATE: _____
REV. DATE: _____
REV. DATE: _____

JOB NO. XXX

SHEET NUMBER _____

A CUSTOM HOME FOR:

THE LAW FAMILY

TO BE BUILT AT:

1060 OAKVALE RD

1060 OAKVALE RD.
FRUIT COVE, FL.
32259

PLAN

DREAMBUILDER 27

TRADE VENDOR M/D/Y TRADE LANDSCAPE VENDOR M/D/Y

TRADE VENDOR M/D/Y TRADE SURVEYOR M/D/Y

CONCRETE SQUARE FOOTAGES (±)


DRIVEWAY: 905 ENTRY WALK: 98 STREFF WALK: XXXX

DRAWN BY: PATRICK MANGIUS
2023 OLD TWE. AVE. ST.
AUGUSTINE, FLA. 32084
904-810-5904
DATE: 2-29-12

A-1

TRADE VENDOR M/D/Y TRADE VENDOR M/D/Y

STRICT VENDOR M/D/Y

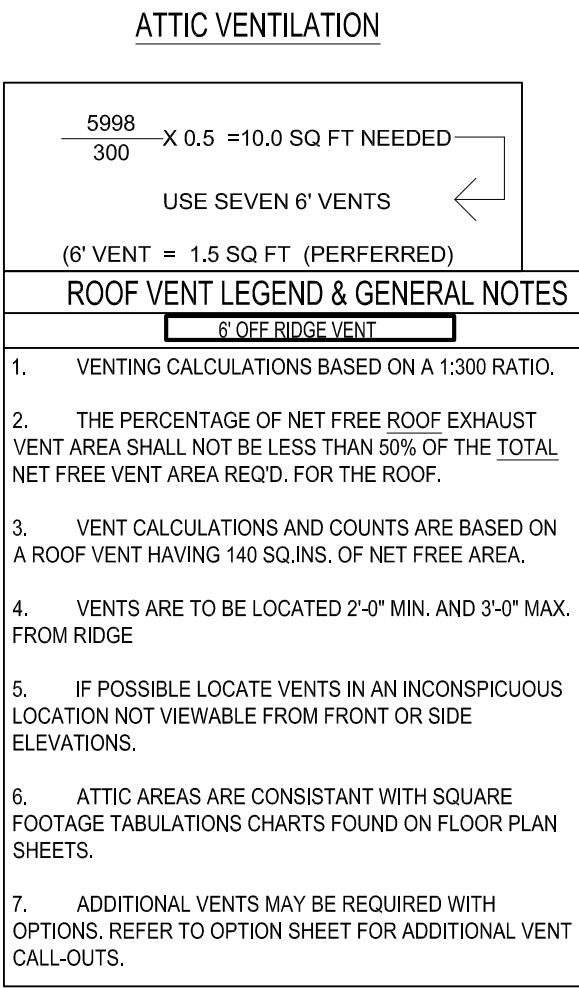

DRAWN BY: PATRICK MANGUS
2023 OLD TMYE. AVE. ST.
AUGUSTINE, FLA. 32084
904-810-5904
DATE: 2-29-12

PLAN
DREAMBUILDER 27

A CUSTOM HOME FOR:
THE LAW FAMILY

1060 OAKVALE RD.
FRUIT COVE, FL.
32259

1060 OAKVALE RD





DREAMBUILDER
CUSTOM HOMES, LLC

CUSTOM HOMES, LLC

DRAWN PM	CHECKED XXX
SCALE 1/4"=1'-0"	
DATE: 7/7/14	
CHANGES 12/17/14	
REV. DATE	
REV. DATE	
REV. DATE	
JOB NO. XXX	
SHEET NUMBER	

A-2

  [illegible]



PLAN

DREAMBUILDER 27

A CUSTOM HOME FOR:

THE LAW FAMILY

1060 OAKVALE RD.
FRUIT COVE, FL.
32259

TO BE BUILT AT:
1060 OAKVALE RD

DRIVEWAY:	905	ENTRY WALK:	98	STREET:
CONCRETE SQUARE FOOTAGES (±)				


NOTAGES (±)	
98	STREET WALK: XXXX



DREAMBUILDER
CUSTOM HOMES, LLC

A-3

TRADE	VENDOR	M/D/Y	TRADE	VENDOR	M/D/Y	TRADE	VENDOR	M/D/Y	TRADE	VENDOR	M/D/Y	CONCRETE	SQUARE FOOTAGES (±)
STRUCT.			A/C			LANDSCAPE			SURVEYOR			DRIVEWAY:	905
												ENTRY WALK:	98
												STREET WALK:	XXXX

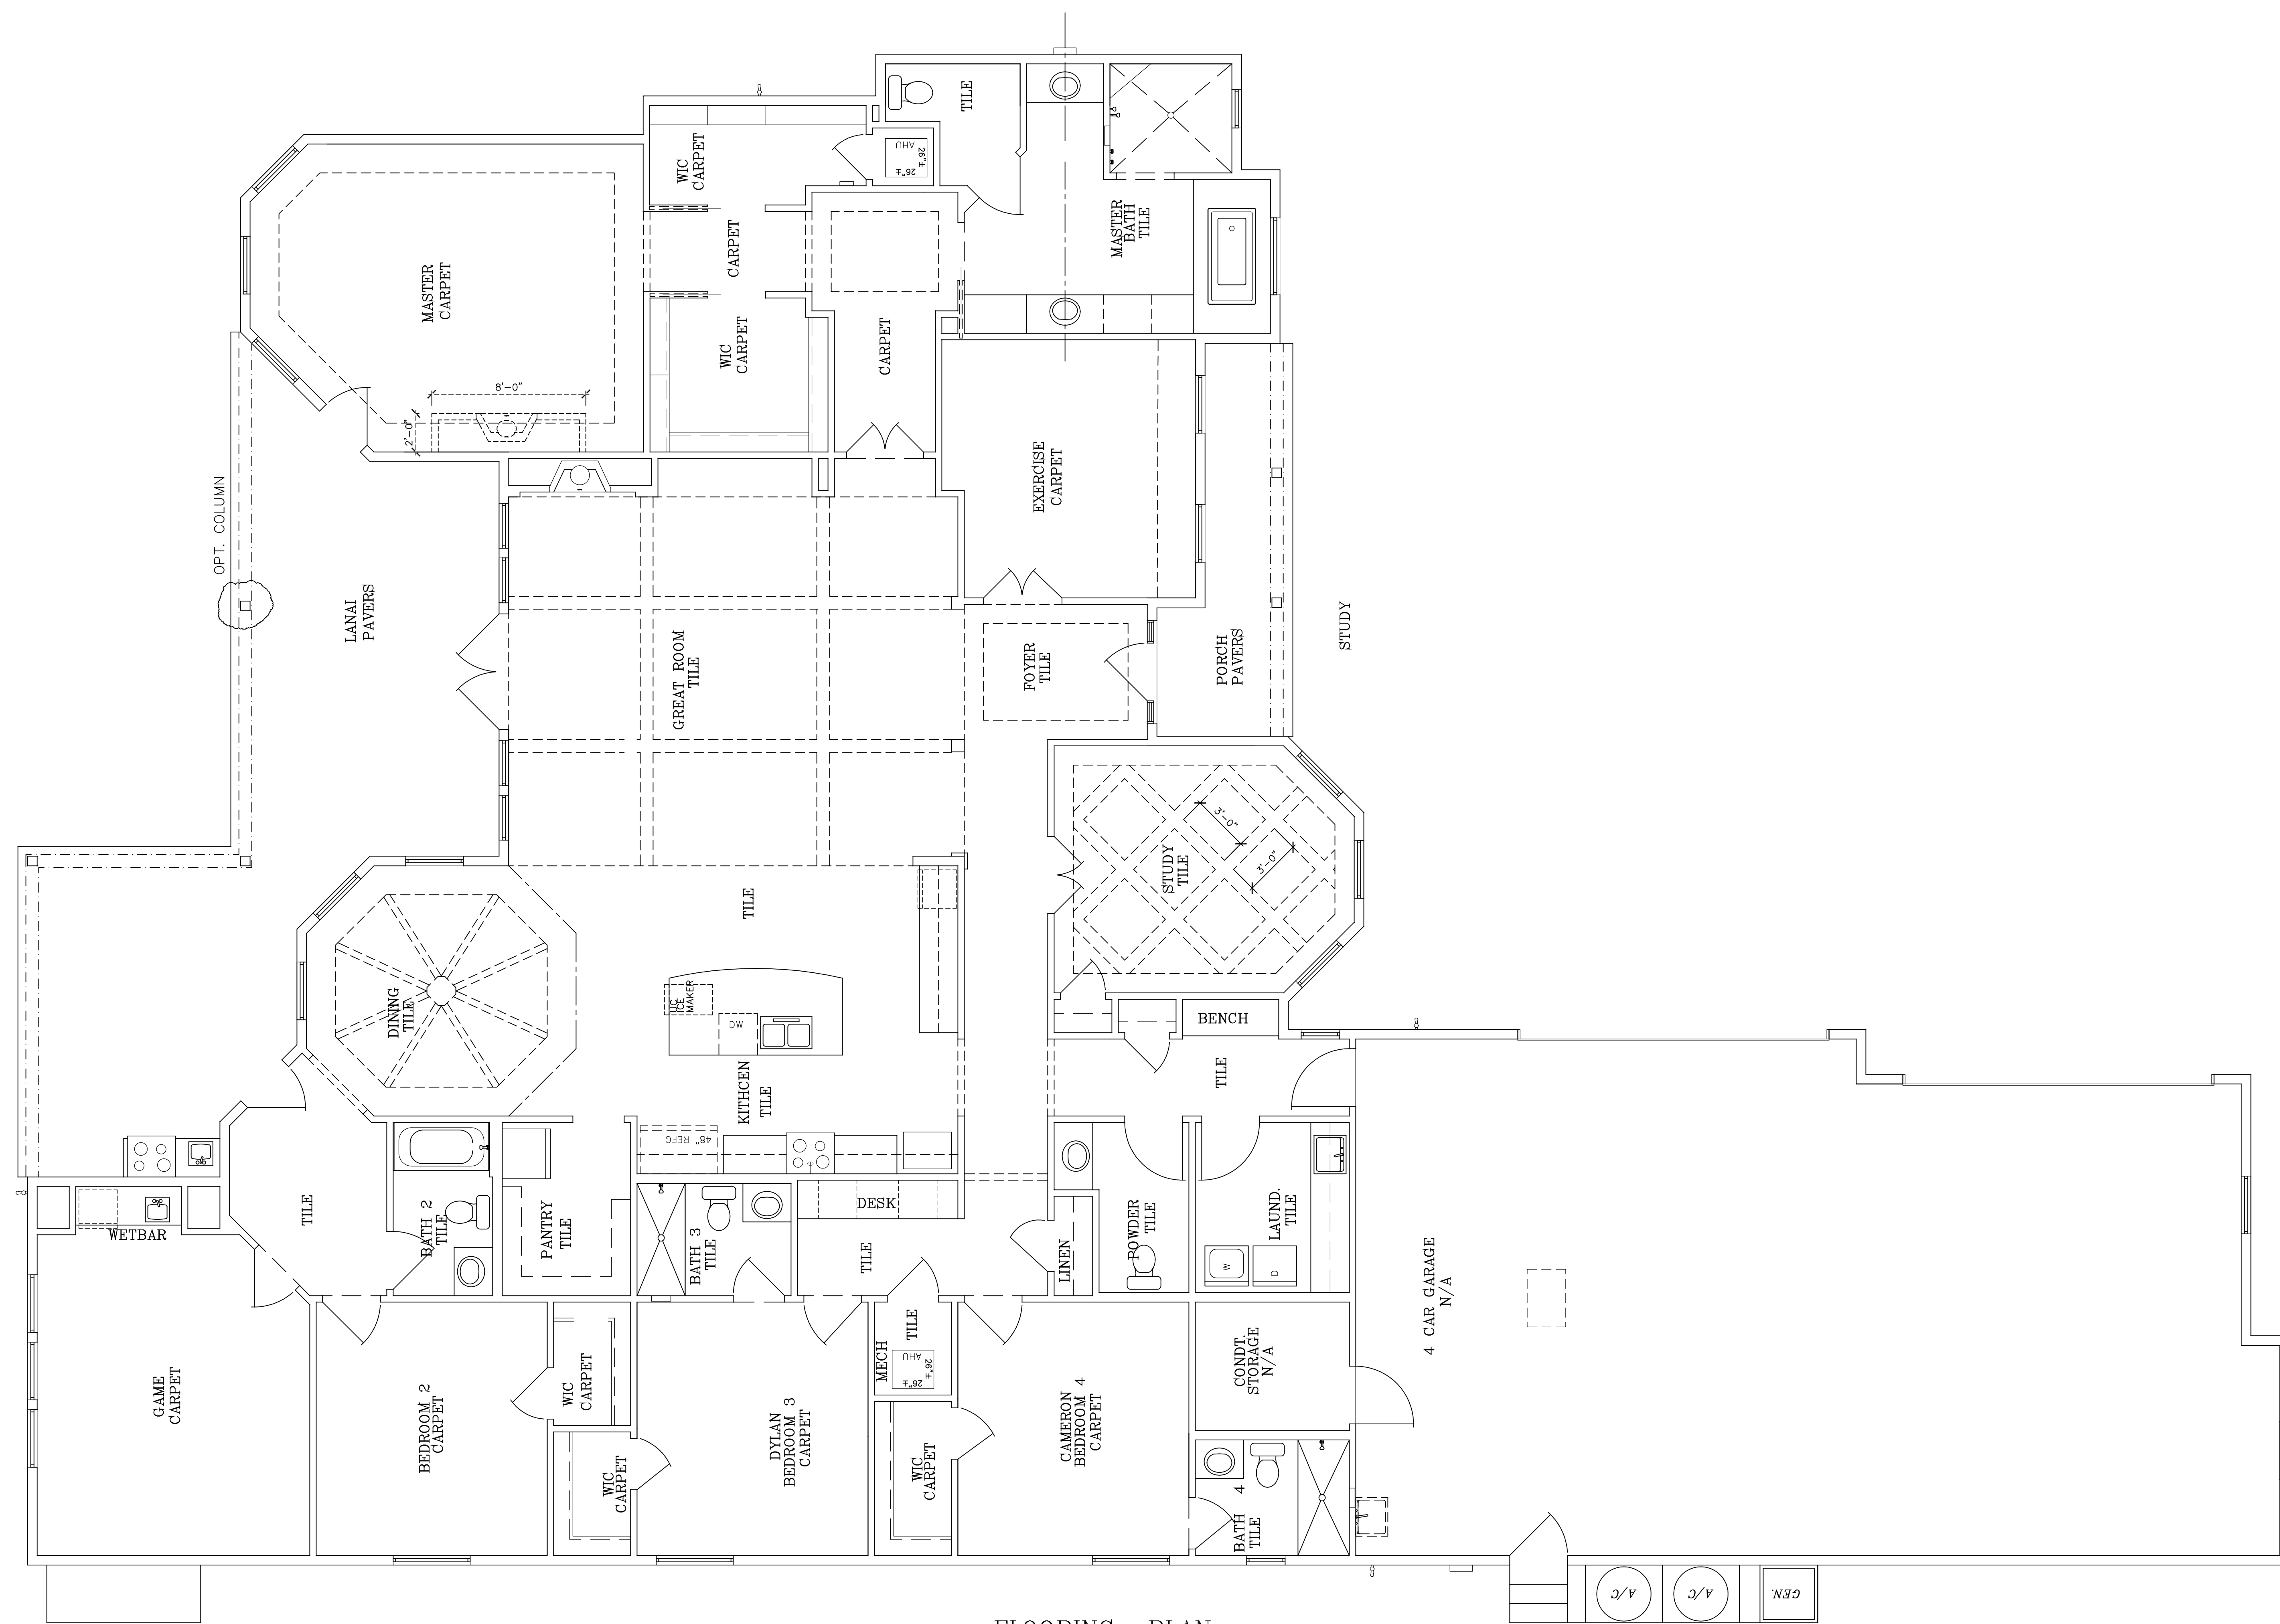

DRAWN PM	CHECKED XXX
SCALE 1/4"=1'-0"	
DATE: 7/7/14	
CHANGES	12/17/14
REV. DATE	
REV. DATE	
REV. DATE	
JOB NO.	XXX

A-4



DREAMBUILDER
CUSTOM HOMES, LLC


A CUSTOM HOME FOR:
THE LAW FAMILY
TO BE BUILT AT:
1060 OAKVALE RD

PLAN

DREAMBUILDER 27

DRAWN BY: PATRICK MANGUS
2023 OLD TMYE. AVE. ST.
AUGUSTINE, FLA. 32084
904-810-5904
DATE: 2-29-12

[illegible]

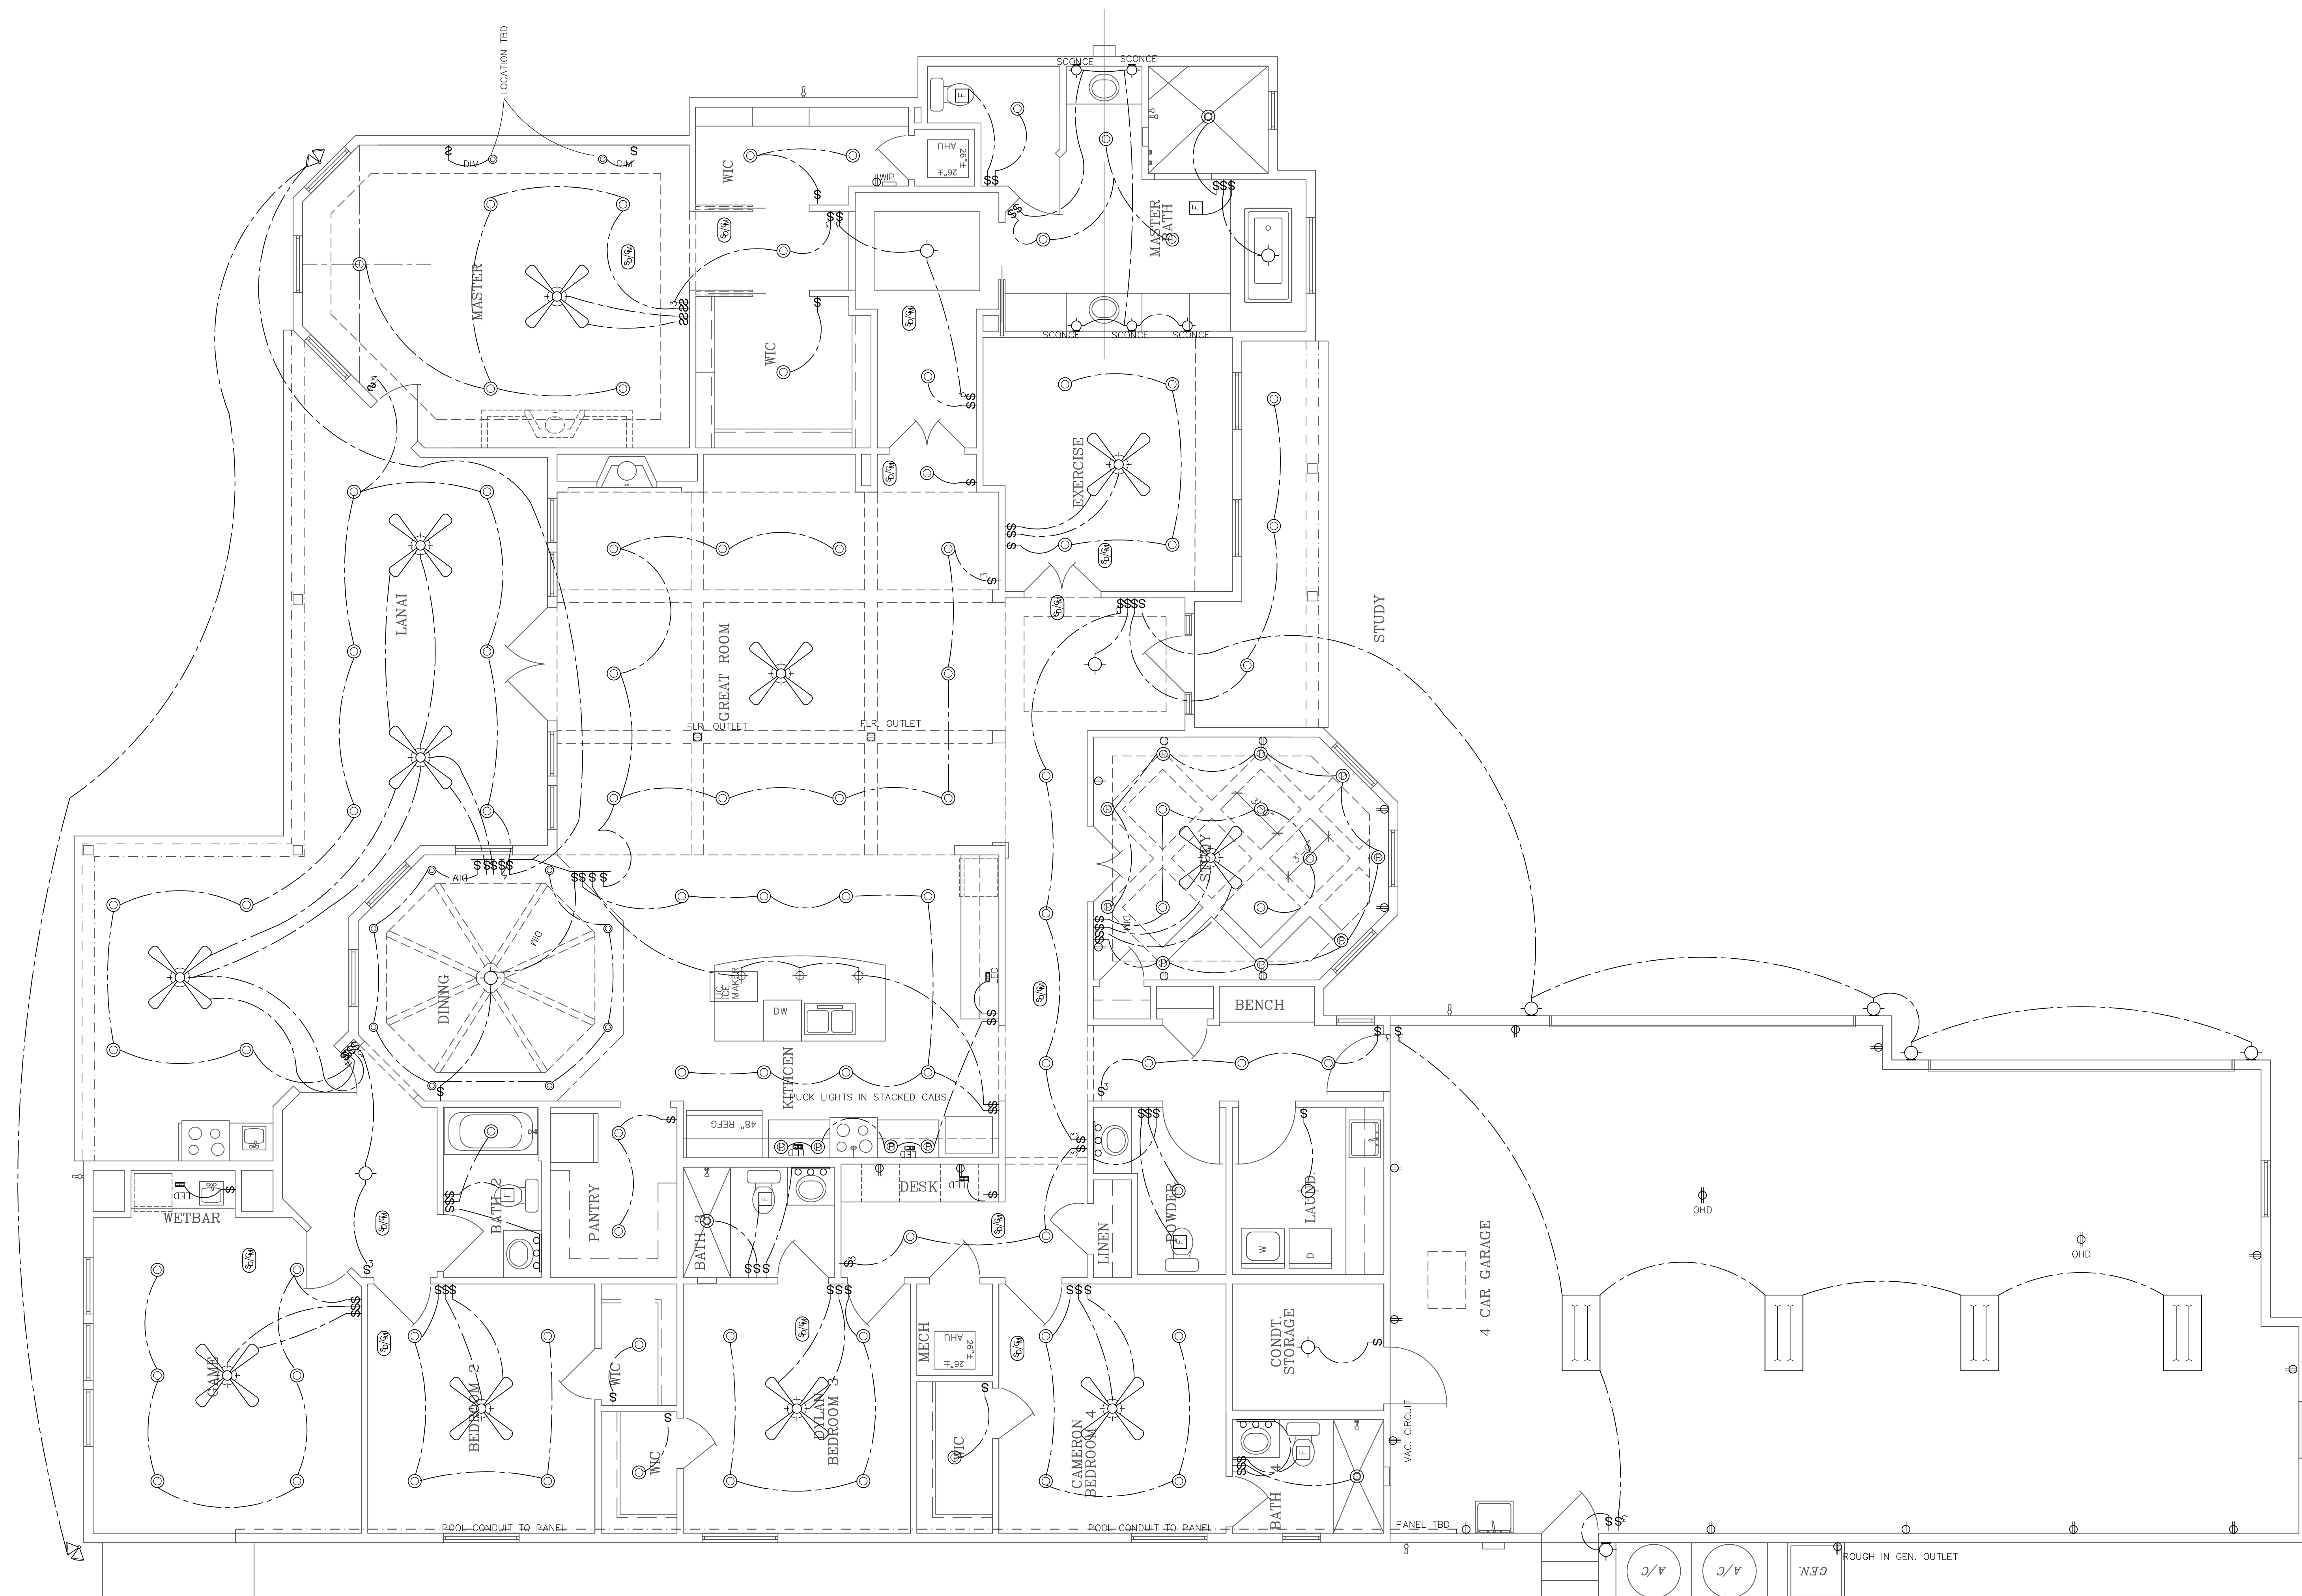

E L E C T R I C A L L E G E N D

THE LOCATIONS OF PLACEMENT OUTLETS, SWITCHES, AND FIXTURES ON THIS PLAN MAY VARY IN THE ACTUAL HOUSE DUE TO LOCAL BUILDING CODES AND OCCUPANCY REQUIREMENTS. ALWAYS CONSULT THE LOCAL ELECTRICAL DEPARTMENT TO MATCH THE LOCATIONS AS CLOSE AS POSSIBLE.

B E L O W A R E T H E M O S T R E Q U E S T E D L O C A T I O N S .

	DOUBLE OUTLET		WEATHER-PROOF OUTLET
	MASTER BEDROOM		CEILING OUTLET
	WALL LIGHT		FLOOR LIGHT
	DISH. FLOATING		SWITCH
	PHONE OUTLET		3-WAY SWITCH
	CABLE TV OUTLET		ON/OFF SWITCH
	WIPE/GRAZE FOR CEILING FAN W/ LIGHT		LIGHT FIXTURE
	WIPE/GRAZE FOR CEILING FAN (W/ NO LIGHT)		EXHAUST FAN
	STANDARD FIXTURES		CARBON MONOXIDE
	UNDER CABINET LIGHTING		VANITY FIXTURES
	ELECTRICAL SERVICE PANEL		FOCAL FIXTURES
			HALL FIXTURES
			EXHAUST FAN W/ LIGHT

4. INSTALL SMOKE/CARBON MONOXIDE DETECTORS PER CODE.

5. INSTALL GFI'S PER CODE.

6. INSTALL A/C'S PER CODE.

Garage doors:							
Quantity	Manufacturer	Style	Size	Color	Windows	Hardware	Notes
2	Overhead Door	Courtyard 105T	10x8	White	None	Strap latches Spindle tray plate Spindle lift handles	
Notes: - Garage door opener (g2), 3/4 HP chain or belt drive; supplier to specify - Garage entry (g1): supplier to specify							
Exterior doors:							
Location	Manufacturer	Style	Size	Notes			
Front door		Storm door: final spec TBD	3000 w/2-1.0 side lights				
Garage to house and garage service door		Flingspan smooth matching interior door profile	3000 each				
Garage to rear land		Flingspan smooth single full lite	6000	No railing, low-e			
Master bedroom and rear entry to land		Flingspan smooth single full lite	3000 each	No railing, low-e			
Notes: - Composite thresholds and jamb - Weatherstripping and sweeps							

interior doors/trim materials Note: All materials primed whenever possible.	
interior doors	Masonite Molded Panel Series 2 Panel Square Top Smooth Door, hollow core
HVAC doors	Solid
Pantry barn door	Bunka Barn Door

					diverter valve
Bath #2 inlet	1	Kohler	Highline	K-3979	White 2 pieces, 12" each, 1.6 GPM, elongated constant height
Bath #2 sink	1	Kohler	Verity	K-2882	White Undermount
Bath #2 sink faucet	1	Kohler	Brandford	6600	Chrome Single handle
Bath #3 shower faucet	1	Delta	Victorina	172755	Brilliance stainless Use Delta 57067 shower head and RP52123 diverter arm; also include Delta 57021 + diverter valve
Bath #3 inlet	1	Kohler	Highline	K-3979	White 2 pieces, 12" each, 1.6 GPM, elongated constant height
Bath #3 sink	1	Kohler	Verity	K-2882	White Undermount
Bath #3 sink faucet	1	Delta	Victorina	55467	Brilliance stainless Single handle
Bath #4 shower faucet	1	Moen	90 Degree	152712 use 3979 handheld	Chrome Use Moen Aris 5310 shower arm; include matching diverter (1" valve, one valve system)
Bath #4 inlet	1	Kohler	Highline	K-3979	White 2 pieces, 12" each, 1.6 GPM, elongated constant height
Bath #4 sink	1	Kohler	Verity	K-2882	White Undermount
Bath #4 sink faucet	1	Moen	90 Degree	36705	Chrome Single handle
Hot water heater	2				Tandem by others

Bath #4	Wall	Tessco Silk	Caté	side to side 32x26 vertical straight	380 new tape	12"x12" water resistant per plan	
Bath #4	Unit	Durable Cohesion glass	White wains CW21	3x1 glass mosaic, 4" x 6"			See detail
Bath #2	Fan	Eryoncom	White suede gravel 0288	2x2 straight			
Cabinets:							
* Notes: Basic finish selections below. See vendor's separate cabinet plan document for specifics; layout and projections. * Notes: Touch-ups for all cabinet finishes must be provided for homogenous. * Notes: Antimicrobial specification: APC, 1% with clear double coating. * Notes: Install profile and bath #2 number of side studs. See below for exact placement.							
Master Bedroom	ArtsCraft	White/red	White/red				Hardware
Kitchen	ArtsCraft	White/red	White/red	All wall cabinet, painted white; island, unit white			JA Hardware: 650-12804 handles, 650-091 pulls
Masterroom	ArtsCraft	White/red	White/red	White/red			JA Hardware: 650-12804 handles, 650-091 pulls
Laundry	ArtsCraft	White/red	White/red	Painted white			JA Hardware: 650-12804 handles, 650-091 pulls
Hall cloak	ArtsCraft	White/red	White/red	White/red			JA Hardware: 650-12804 handles, 650-091 pulls
Guest room media	ArtsCraft	White/red	White/red	White/red			JA Hardware: 650-12804 handles, 650-091 pulls
Guest room bar	ArtsCraft	White/red	White/red	White/red			JA Key Item: 14608 handles, 650-091 pulls
Master bath	ArtsCraft	White/red	White/red	White/red			JA Key Item: 435-3608 handles, 650-091 pulls
Powder	Hardware Resources	VAN027-1-40W (13" w)		Alber black vanity/wall mirror top, sink & splash			Included
Bath #2	Hardware Resources	VAN027-2-40W (26" w)		Essence vanity, DO NOT			Included

[illegible][illegible]

Flypaper (grout notes): see detail						
Flypaper: Marble: Succumbed: Hearts:	30" gray, FMI Chateau, direct vend, with suitable, backspace interior, chess face; gas connection by others Wired Underside Stone Hillstone, Venis, gray marble Wired, color less 3.2" AV					
Flypaper (counter backspace): OPTIONAL ; see detail						
Flypaper: Marble: Succumbed: Hearts:	30" gray, FMI Chateau, direct vend, with suitable, backspace interior, chess face; gas connection by others Wired By others Fly by others; less on floor					
Paint:						
Interior: Ceiling (beamed on colored felled): Columns (painted): Ceiling treatments: Finger colling: Beams and truss: Lantern shades:	Color SW7033 accessible beige SW7005 pure white SW7005 pure white SW7024 charcoal SW7005 pure white SW7024 iron white	Fields: Flat Flat Semi gloss Semi gloss Flat	Exterior: Front door Side door Porch railings Lip sliding Stairs Walls Garage doors Exterior doors	Color SW7024 Chestnut SW7031 sage green SW7042 drab white	Notes Stain	
Carpets:						
Carpets:	Manufacturer Incasula Wils	Style Mythic W/rd	Color 3.3 black walnut	Underlayment RIP pad	Locations All bedrooms, game room, recreation	Notes

Batch #3	Arbolito vlt	Tongue sample	LOG INCLUDED TOPSIDE		JA Cante: 595-9504 Hards: 595-201 pull JA Key Ring: 14650N Hards: 4050N pull
			Udako	Sengobila	
Batch #3	Arbolito vlt	Tongue sample	Udako	Sengobila	

Countertops:

* Note: A 15-year under-slab test applied to all granite countertops.

Location	Material	Color	Edge	Backsplashes	Slab	Notes
Refrigerator	Cambridge quartz	Thompson	Exposed 180° (exposed) Inside "Mosaic" (exposed 180°)		By others	
Midulooks	Wood	Cambridge quartz	Whitney	Exposed 180°	None	Calderon top
Head sink	Wood	Cambridge quartz	Whitney	Exposed 180°	None	Calderon top
Great room media	Wood					Calderon top
Guest room bed	Cambridge quartz	Purple	Exposed 180°	None	By others	Calderon top
Master's dressing	Cambridge quartz	Darkburgan	Exposed, inside edge only	n/a	n/a	12" wide curved edge under island
Master's fireplace hearth	Cambridge quartz	Darkburgan	Exposed	n/a	n/a	32" x 54" on floor as fireplace hearth
Master's vanity	Cambridge quartz	Darkburgan	Chips	Standard	By others	By others
Master's toilet	Cambridge quartz	Darkburgan	Chips	Standard	By others	By others
Prohibit	Cambridge quartz	Darkburgan	Chips	Standard	By others	By others
Batch #3	Cambridge quartz	Darkburgan	Exposed 180°	Slab, rear only	By others	
Batch #3	Cambridge quartz	Darkburgan	Exposed 180°	Standard	By others	

Ultram from underfoot lights	n/a								LED (Bau)
Appliances: (NOTE: Thermador "Professional" is not identical to GE Monogram "Professional")									
Appearance	Location	Manufacturer	Model Number	Holds	Notes				
Cooktop	Kitchen	Thermador	GC96GFS	Stainless, Professional	36" W x 24" D				
Oven	Kitchen	Thermador	PED80S	Stainless, Professional	17" W x 24" D = VENTROL COOK chv				
Wd wss	Kitchen	Thermador	PC0R01	Stainless	Single underneath				
Dishwasher	Kitchen	GE Monogram	ZM27ASRS	Stainless, Professional	American 260V				
Refrigerator	Kitchen	Thermador	TBBK2CNC	Stainless, Professional	48" built-in refrigerator and freezer				
Dishwasher	Kitchen	Thermador	DWP6000RP	Stainless, Professional					
Freezer	Kitchen	Thermador		n/a	5 1/2 ft. By owner				
Weather and dryer					By owner				
Water softener					By owner				
GWH					By others				
Furniture:									
Refridnawater	Style	Pattern	Color	Seera	Locations				
Ironman	Mighty Circle throne	Random			1° - driveway, entry walk 2° - all porches, beach and terrace; include copying on all steps and porch edges				
Summer kitchen:									
= Aluminum frame construction with fire resistant backboard final sheathing by others									
= Greater countertop; see notes									
= Many 2x2-4x4-Inner GEM WITH Riser floor									

					All purchases: 140 T&E plan, front to back	
Chairs (seated rows)					For and with 32 to waistline, iron backs with neck support	
Chairs (standing for juries)					None	
Chair cushions (for juries)					Great cases, dining cases, master benches, study	
Other cushions					Wood all with stain	
Hardware					1 finger door hardware: Eastport Ashfield, iron black - Other doors: Eastport Ashfield, iron black - Flanges and door stops to match hardware finish	
Painting:						
Note: Finish pricing must be finalized. Planes to supply coordinating paints (panels, hardware, doors, etc) in matching finish.						
Item	Quantity	Brand	Model Name	Model #	Finish/Color	Notes
Kitchen sink	2	Vigo	n/a	VGR200BKL1	Stainless	3" farmhouse; includes sink and strainers
Kitchen sink faucet	1	Delta	Victorian	995-051	Brilliance stainless	2 hole
Kitchen pot filler	1	Delta	Traditional	13771F	Brilliance stainless	Over countertop
Laundry sink	1	Storling	Latitude	995-4	White	Victrol under utility
Laundry sink faucet	1	Moen	Carnegie	59053	Chrome	Two hole
Hot bar sink	2	Eliay	Darbyton	DOX0H220	Chrome	Undermount 12"x14"
Hot bar faucet	2	Moen	Levee	5200	Chrome	Single lever handle, use hole

[illegible]

Room #1	Cambley quarter	How Many	Second TRM	Standard	By others			
Specifications:								
Showering:								
Location	Style	Finish	Number of Showers	Notes				
Shower closet	Cage: Shower stand, w/wood	w/wood	5	Pv. plates				
Pantry	Cage: Shower stand, solid	w/wood	1					
Linen	Cage: Shower stand, w/wood	w/wood	5					
All other rooms	Cage: Shower stand, w/wood	w/wood	1					
Dressrooms:								
Room	Style	Frame/Exterior	Finish	Notes				
Room #1	Door and panel	Formed	Brushed nickel	To 2' height				
Room #2	Door and panel	Formed	Chrome	To 2' height				
Mirrors and Accessories:								
* Note: TR bulkers are positioned as if one is sitting on the commode								
* Note: Indicator to walk twice with bulker prior to installation to determine first placement of accessories								
Room	Room Interior	Quantity	Manufacturer	Style	Model #	Finish	Location	Notes
Master lavatory	Master lavatory	2	Master lavatory	Plastic glass			Each vanity	Finished with cabinetry + stainless commode, link d0128
Master lavatory	TR lavatory	1	Molten	Retiatory	TR6003	Chrome	Left of toilet	
Master lavatory	TR lavatory	1	Molten	Retiatory	TR6003	Chrome	Left of shower entrance	
Master lavatory	Towel bar	2	Molten	Retiatory	TR6224	Chrome	Front of lavatory	24"

- Stainless steel endowment bar/angle stick (supplier to specify)
- Fastener: two-handle high arc (supplier to specify)

Powder bath sink	3				by others
Powder bath faucet	2	Escher	Archer	6-23576-4	Chrome 8" widespread
Powder bath toilet	2	Escher	Hoffberg	6-9979	White 2-piece, 32" rough, 1.6 GPF, elongated comfort height
Master bathtub	1	Escher	Underseaw	E-1121	White 60"x66"x28" undermount bathtub
Master bathtub faucet	3	Moen	Rutledge	12925	Chrome 60"x66"x28" w/roughed
Master shower faucet	1	Moen	Rutledge	2056-shower system	Chrome 1" w/valve and hand spray valve DO NOT INSTALL bathtub shower arm/cock, install one Moen 5213 VirtuMetal shower arm with Moen 5212 Moen "90" shower head (chrome) SHOWER WITH HULDER AT TOP OUT FOR SPECIES LOCATIONS FOR THESE FITTINGS PRIOR TO INSTALL
Master toilet	1	Escher	Hoffberg	6-9979	White 2-piece, 12" rough, 1.6 GPF, elongated comfort height
Master vanity sink	2	Escher	Archer	E-2355	White Undermount
Master vanity sink faucet	2	Moen	Rutledge	736205	Chrome 8" widespread
Both E2 bathtubs	3	Escher	Valberg	E-736	White Right-hand drain
Both E2 bathtub faucets	3	Moen	Burford	12153	Chrome w/valve should handle shower Moen 5213 at shower

Master bath	Part	605608	American Recess, restle	5 cm straight	Kabukia cream	start and 6" up
Master bath	Shower doorway pencil	607280	Royal Ambler Pul flares	On outside of shower entrance	Kabukia cream	See detail
Master bath	Shower doorway chair (on a tibia)	605948	Queen Bidge Pul Sonnert	On outside of shower entrance; also at top of master tub uphol	Kabukia cream	See detail
Bath #2	Floor perimeter	Dablie Ritronhouse	E111 black glossy	60" two rows around perimeter of bath, back	60 charcoal	
Bath #2	Floor rug effect	Dablie octagon with dot	White white 60x60 w/21 dark glossy		60 charcoal	
Bath #2	Wall	Dablie Ritronhouse	E110 white glossy	36" horizontal back	361 light white	
Bath #2	Floor	Dablie Ritronhouse	E111 black glossy	36" horizontal back, two rows at 60" AF	361 light white	See detail
Bath #3	Shower Mirrors	Tensou Mirrors	Edge	36" x 36" light 30x36 horizontal back	3800 haystack	
Bath #3	Wall	Tensou Mirrors	Edge	60" AF	3800 haystack	12"x12" side recessed per plan
Bath #3	Floor	Tensou Mirrors	Universal access 3800	60" AF	3800 haystack	
Bath #3	Part	Tensou Mirrors	Edge	2x2 straight	3800 haystack	

Master bath	Grab bars	2		Moen	Designer's Lifeline	v3 40": B874B283G v3 48": B5738383G	Brushed nickel	right of vanity On each side of toilet	
Powder	Mirror	1							By owner
Powder	TP holder	1	1	Kohler	Archer	E-13256	Chrome	Wall to right of vanity	
Powder	Towel bar	1	1	Kohler	Archer	E-13053	Chrome	Wall opposite vanity	24"
Powder	Towel ring	1	1	Kohler	Archer	E-13057	Chrome	Wall right of vanity	
Bath #2	Mirror	1							By owner
Bath #2	TP holder	1	1	Kohler	Fairfax	E-13257	Chrome	Between toilet and vanity or wall opposite	
Bath #2	Towel bar	1	1	Kohler	Fairfax	E-13253	Chrome	Wall opposite toilet	24"
Bath #2	Towel ring	1	1	Kohler	Fairfax	E-13265	Chrome	Wall to right of vanity	
Bath #3	Mirror	1			24x36 rectangle translucent beveled edge				Mount 4 – 67" above vanity
Bath #3	TP holder	1	1	Kohler	Forie	E-13274	Brushed nickel	Between toilet and vanity or wall opposite	
Bath #3	Towel bar	1	1	Kohler	Forie	E-13277	Brushed nickel	Wall opposite toilet	24"
Bath #4	Mirror	1			24x36 rectangle translucent beveled				Mount 4 – 67" above